


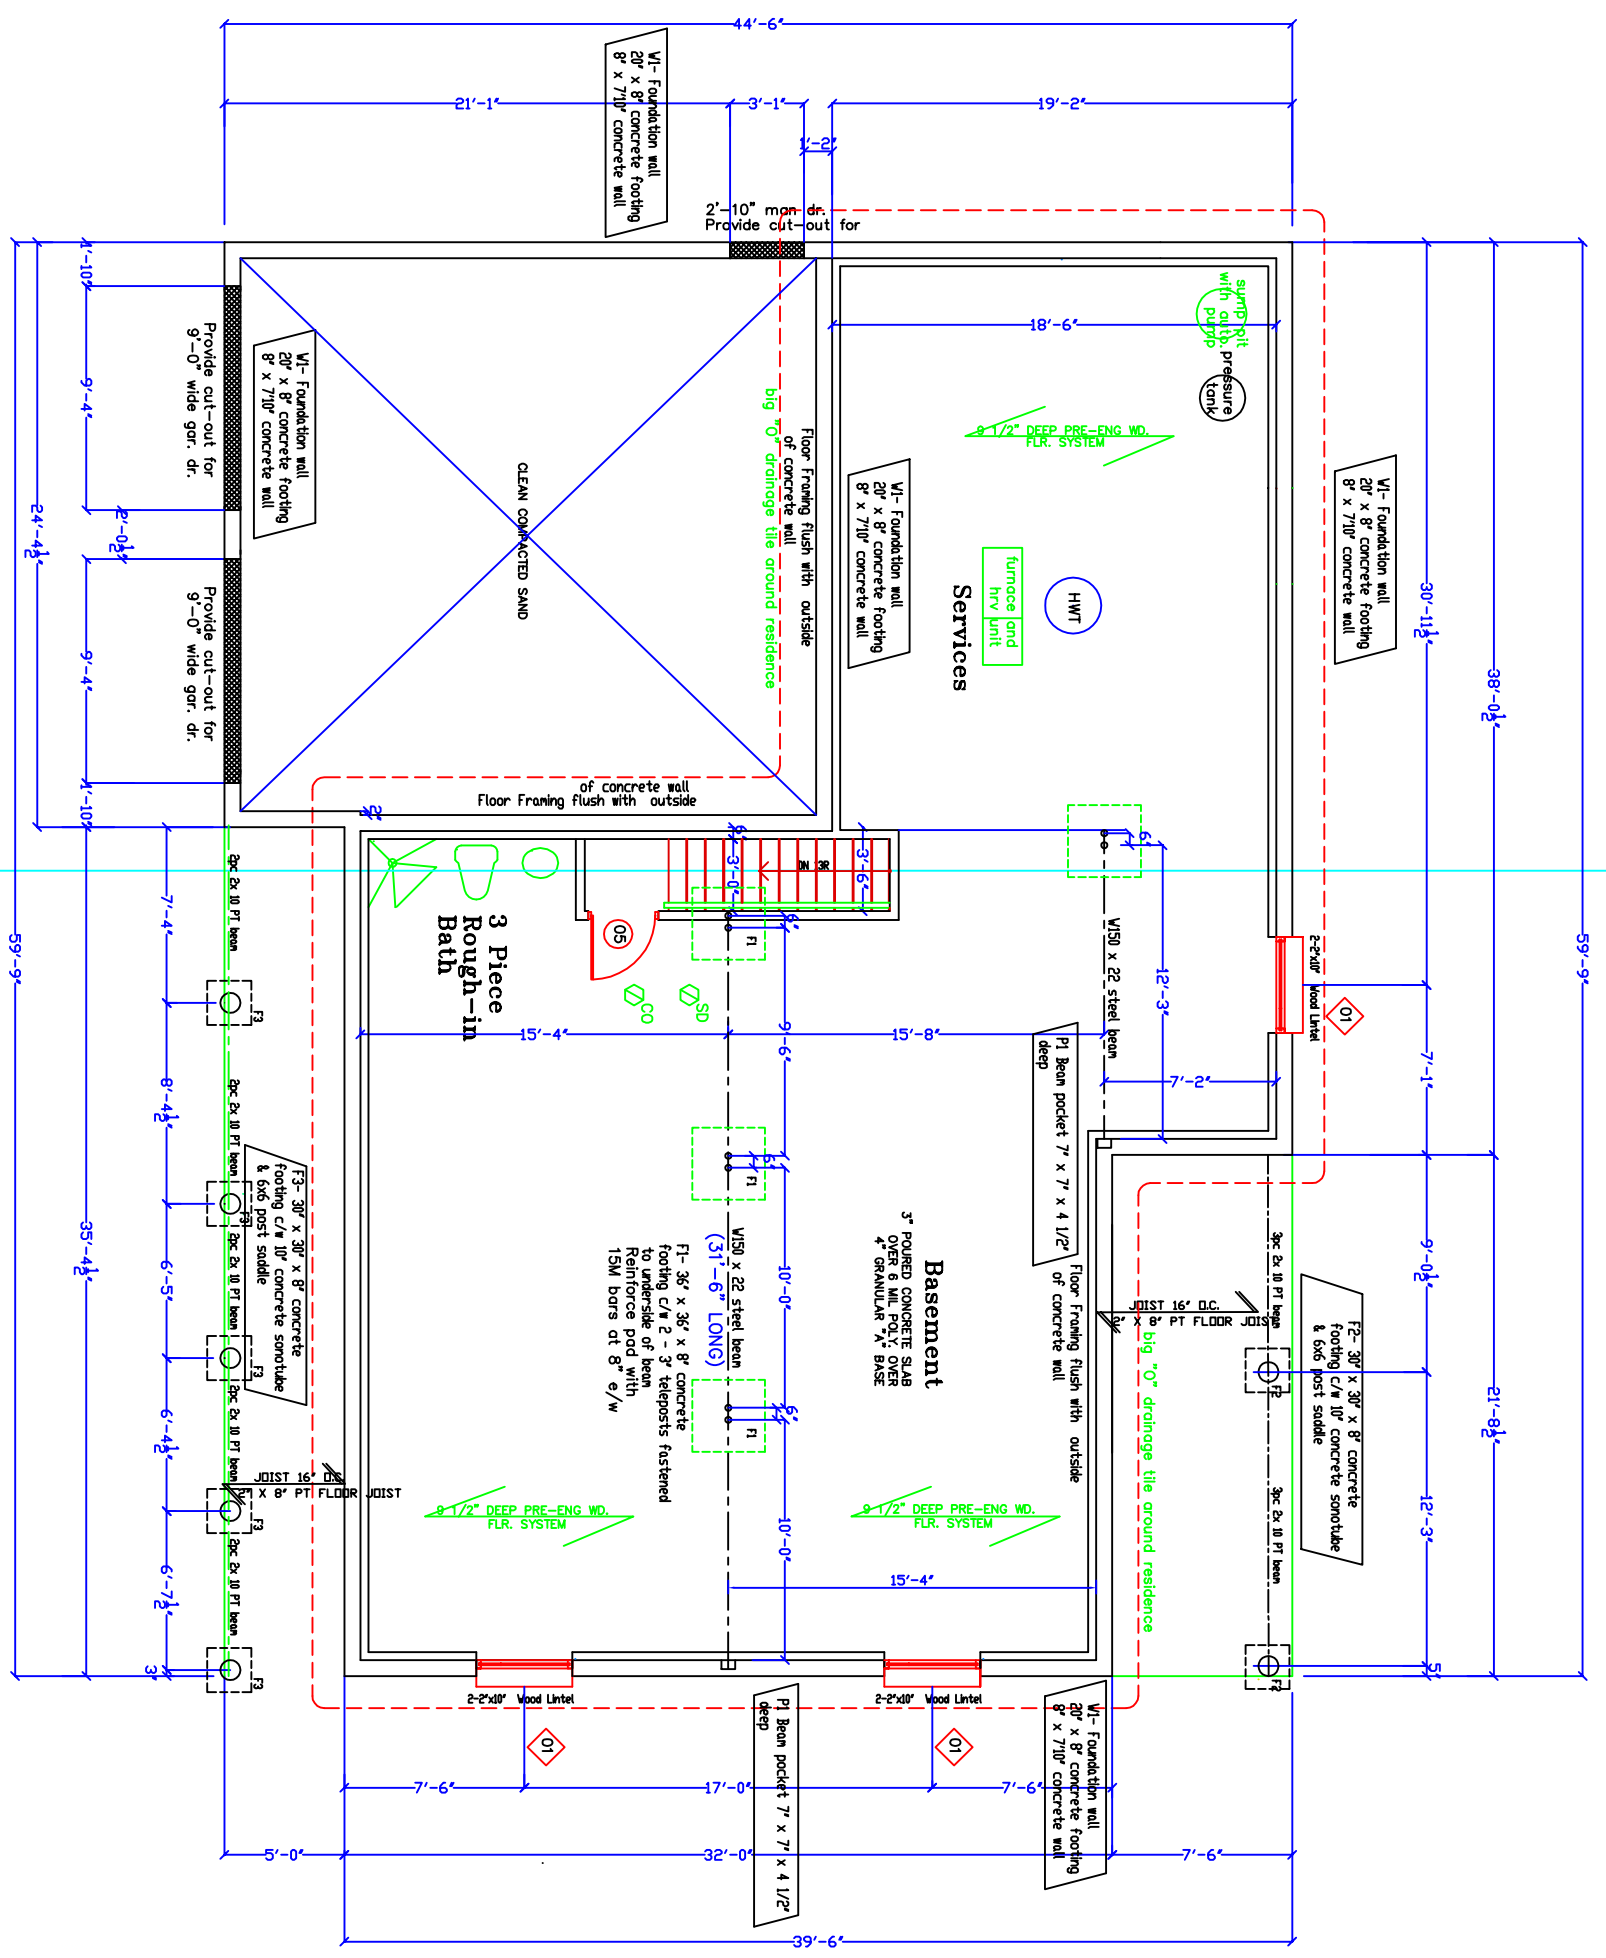


**REVISIONS:**


NO.	REVISION	DATE
1		

**LEGEND:**

-  INTERCONNECTED A/C SMOKE DETECTOR
-  CARBON MONOXIDE DETECTOR
-  BATH EXHAUST FAN



**BASEMENT/FOUNDATION PLAN**



**Ruyf Drafting & Design Inc.**  
 AutoCAD Drafting • Design  
 Graphic Architectural Perspectives  
 RR2 Mountain, On. KOE 150 613-989-3232

Project: **The "Kerri III" Model Home**  
 Client: **ROBINSON CUSTOM HOMES**

Drawing Title: **BASEMENT/FOUNDATION PLAN**

Scale: **1/8" = 1'-0"**  
 Date: **JANUARY, 2016**

Drawn By: **G. RUYF**  
 Checked By: \_\_\_\_\_  
 Approved By: \_\_\_\_\_