


BASEMENT/FOUNDATION PLAN

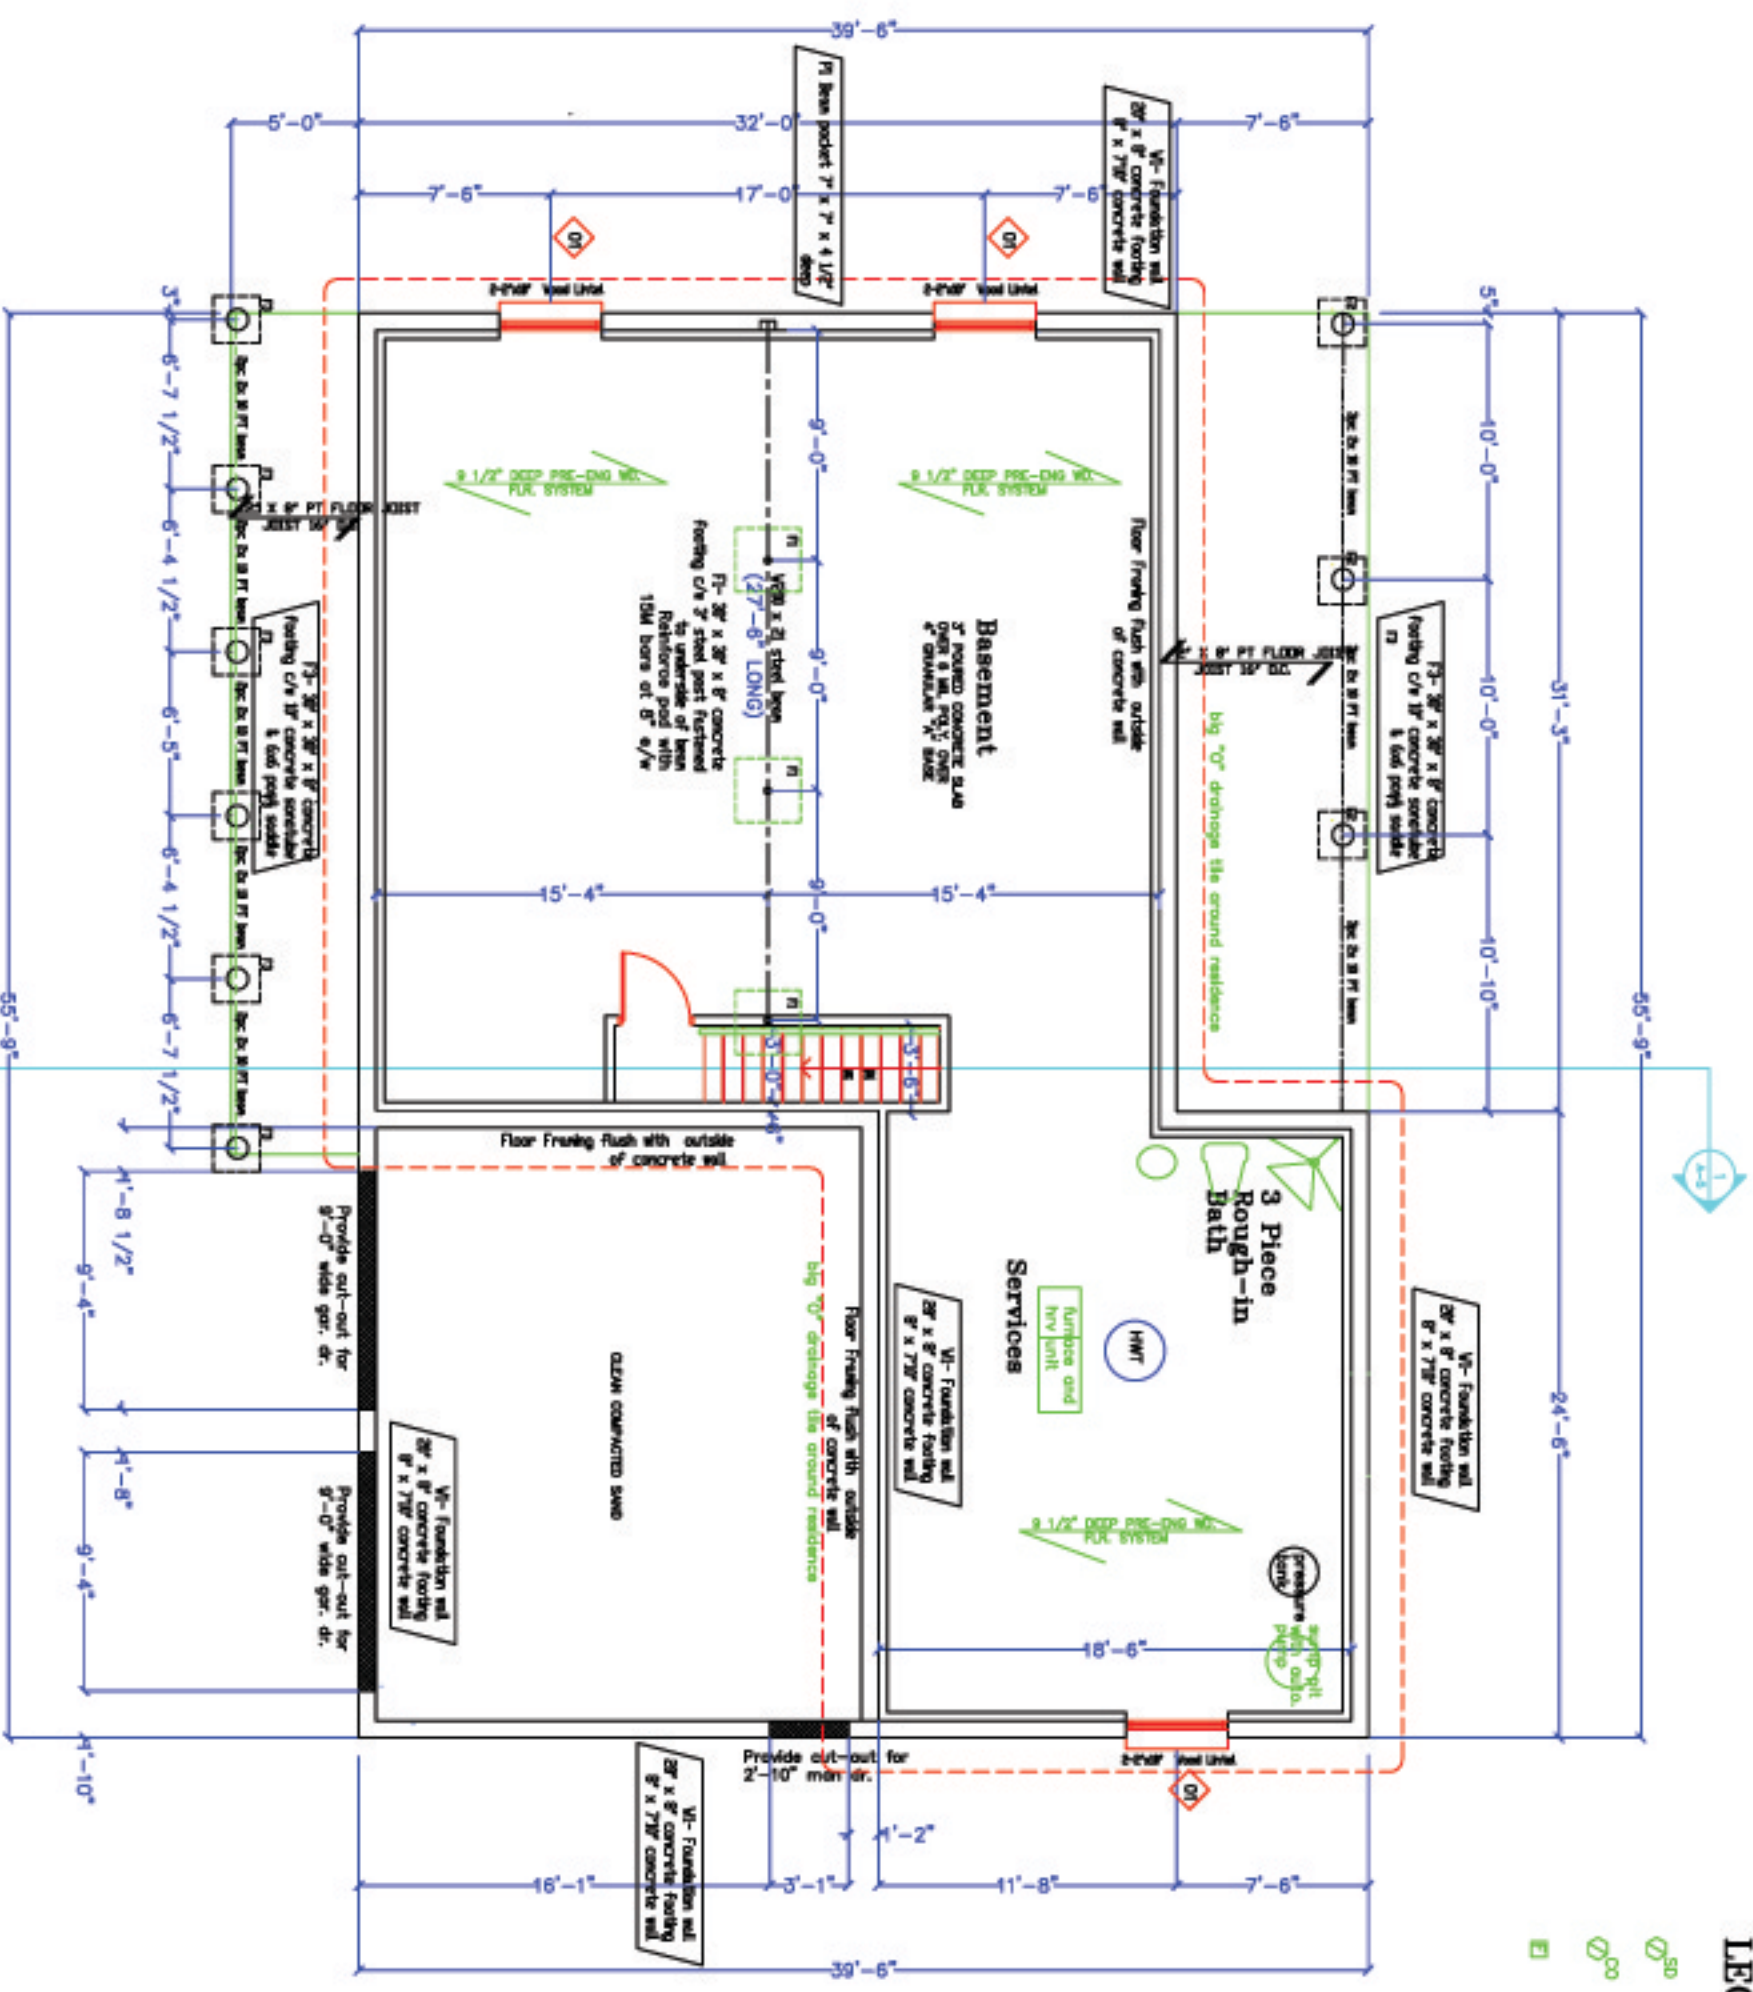

LEGEND:

- INTERCONNECTED A/C SMOKE DETECTOR
- CARBON MONOXIDE DETECTOR
- BATH EXHAUST FAN

REVISIONS:

NO.	REVISION	DATE
1		

LEGEND:

- INTERCONNECTED A/C SMOKE DETECTOR
- CARBON MONOXIDE DETECTOR



Project: **The "Kerri" Model Home**
 Client: **ROBINSON CUSTOM HOMES**
 Drawing Title: **BASEMENT/FOUNDATION PLAN**

Scale: 1/8" = 1'-0"
 Date: JUNE, 2009
 Drawn By: G. RUYF
 Checked By:
 Approved By:
A1 of 5