


REVISIONS:

NO.	REVISION	DATE
1		

LEGEND:

- \$ SINGLE POLE SWITCH
- \$ THREE-WAY SWITCH
- \$ F FURNACE SWITCH
- \$ F DUPLEX RECEPTACLE
- ⊕ CEILING LIGHT
- SD INTERCONNECTED A/C SMOKE DETECTOR
- EP ELECTRICAL PANEL
- CO CARBON MONOXIDE DETECTOR

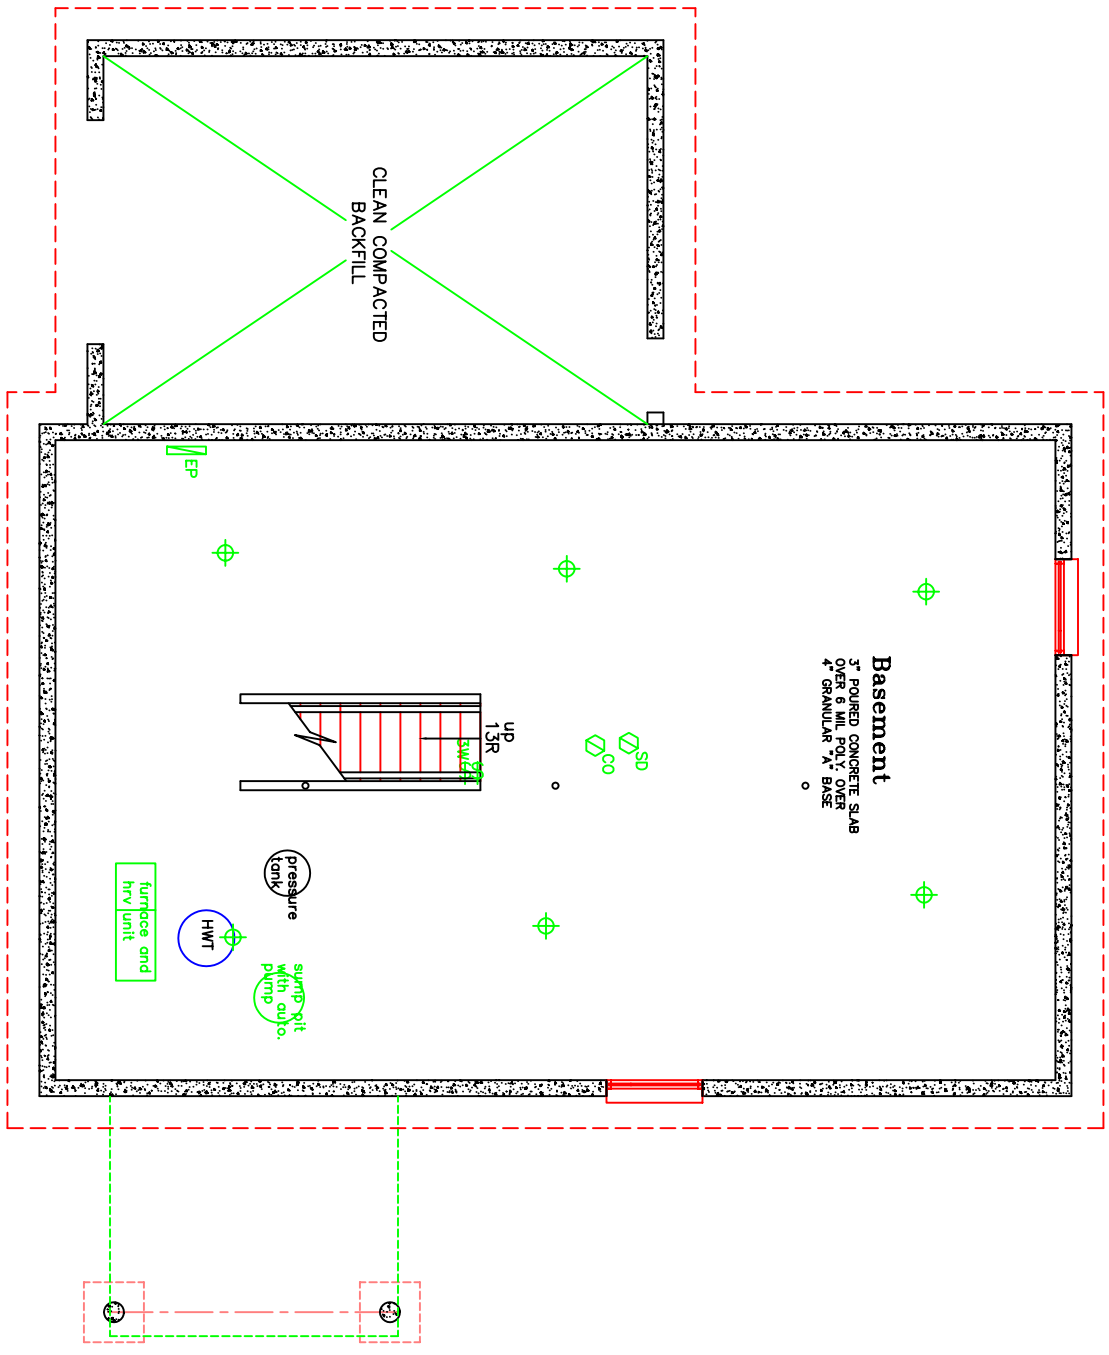

Ruyf Drafting & Design Inc.
 RR2 Mountain, On. K0E 1S0 613-989-3232

AutoCAD Drafting • Design
 Graphic Architectural Perspectives

Project 1204 sq. ft. Bungalow
Client ROBINSON CUSTOM HOMES
 Location 7069 County Rd. 22, Spencerville, ON

BASEMENT ELECTRICAL PLAN

Drawing Title BASEMENT ELECTRICAL PLAN

Scale 1/8" = 1'-0"

Date APRIL, 2013

Drawn By G. RUYF

Checked By

Approved By

Drawing No. E1 of 2